

- NOTES:
- ALL SEWER SERVICES SHALL BE 4" SDR 35 PVC @ 2.0% (MIN) U.N.O.
  - ALL WATER SERVICES SHALL BE 1" TYPE 'K' COPPER U.N.O.

SITE ENGINEER:



CIVIL ENGINEERING ASSOCIATES, INC.  
 10 MANSFIELD VIEW LANE, SOUTH BURLINGTON, VT 05403  
 802-864-2323 FAX: 802-864-2271 web: www.cesa-vt.com

COPYRIGHT © 2019 - ALL RIGHTS RESERVED

DRAWN: SAL  
 CHECKED: DSM  
 APPROVED: DSM


OWNER:  
**HAYSTACK CROSSING, LLC**  
 c/o JOSEPH BISSONNETTE

68 RANDALL STREET  
 SOUTH BURLINGTON, VT 05403

APPLICANT:  
**BLACKROCK CONSTRUCTION, LLC**  
 68 RANDALL STREET  
 SOUTH BURLINGTON, VT 05403

PROJECT:  
**HAYSTACK CROSSING**

SHELburne FALLS ROAD  
 VERMONT ROUTE 116  
 HINESBURG, VERMONT 05461

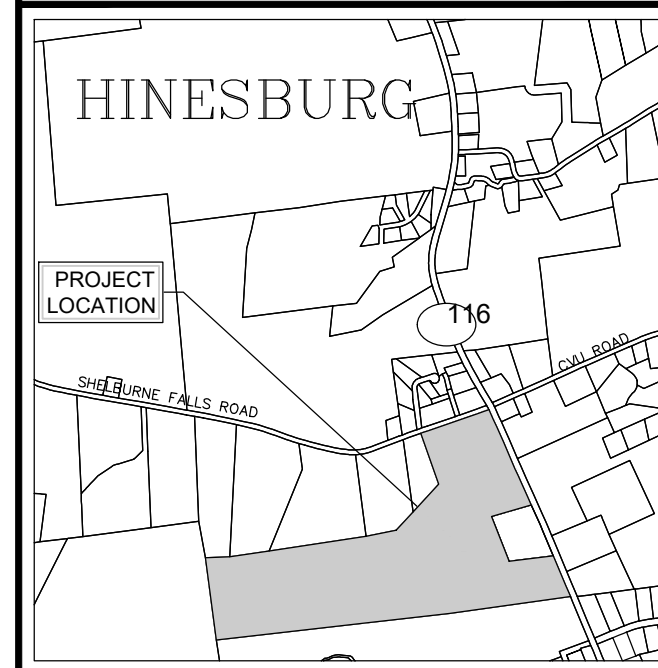

LOCATION MAP  
 1" = 2000'

DATE	CHECKED	REVISION
11/22/19	DSM	TOWN RESUBMITTAL
1/10/20	DSM	UPDATE PER TOWN COMMENTS
3/3/20	DSM	UPDATE PER TOWN COMMENTS
3/4/22	DSM	REV. PER CONDITIONS OF APPROVAL
6/7/22	DSM	REV. PER TOWN COMMENTS

**PARTIAL SITE PLAN  
 WATER & SEWER**

DATE: OCT. 4, 2019  
 SCALE: 1" = 20'  
 PROJ. NO.: 13127  
 DRAWING NUMBER: **C4.1**