



- NOTES:
- ALL SEWER SERVICES SHALL BE 4" SDR 35 PVC @ 2.0% (MIN) U.N.O.
 - ALL WATER SERVICES SHALL BE 1" TYPE 'K' COPPER U.N.O.

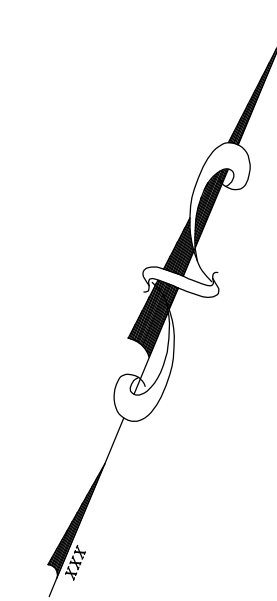


SITE ENGINEER:

 CIVIL ENGINEERING ASSOCIATES, INC.
 10 MANSFIELD VIEW LANE, SOUTH BURLINGTON, VT 05403
 802-864-2323 FAX: 802-864-2271 web: www.ceai-vt.com

COPYRIGHT © 2019 - ALL RIGHTS RESERVED
 DRAWN: SAL
 CHECKED: DSM
 APPROVED: DSM

OWNER:
HAYSTACK CROSSING, LLC
 c/o JOSEPH BISSONETTE
 68 RANDALL STREET
 SOUTH BURLINGTON, VT 05403
 APPLICANT:
BLACKROCK CONSTRUCTION, LLC
 68 RANDALL STREET
 SOUTH BURLINGTON, VT 05403

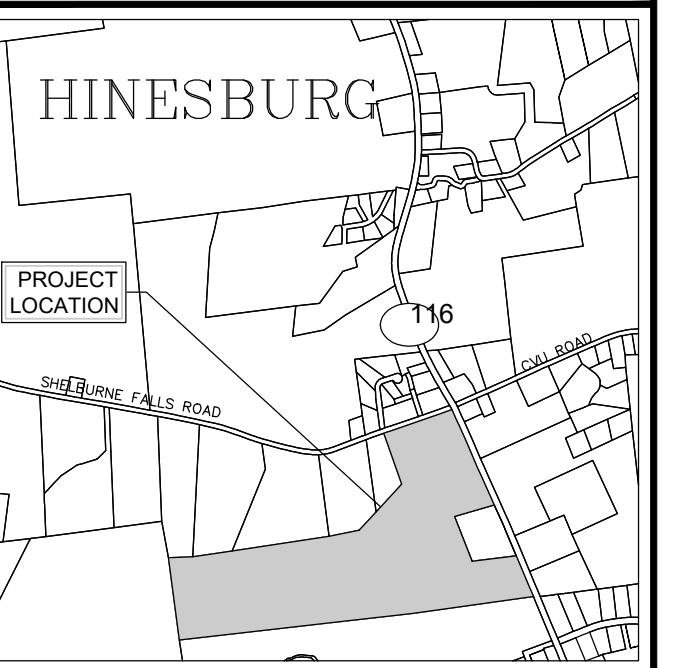PROJECT:
HAYSTACK CROSSING
 SHELBURNE FALLS ROAD
 VERMONT ROUTE 116
 HINESBURG, VERMONT 05461




LOCATION MAP
 1" = 2000'

DATE	CHECKED	REVISION
11/22/19	DSM	TOWN RESUBMITTAL
1/10/20	DSM	UPDATE PER TOWN COMMENTS
3/4/22	DSM	REV. PER CONDITIONS OF APPROVAL

**PARTIAL SITE PLAN
 WATER & SEWER**

DATE: OCT. 4, 2019
 SCALE: 1" = 20'
 PROJ. NO.: 13127
 DRAWING NUMBER: **C4.6**

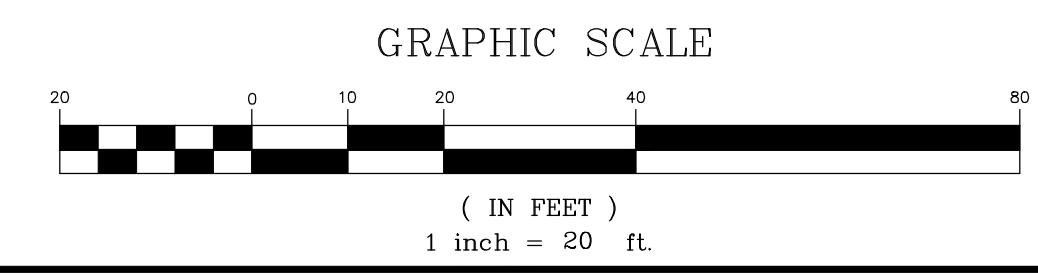

P:\AutoCAD Projects\2013\131271-CADD Files\131271-Dwg\131271-SITE.dwg, C4.6 - W&S, 3/14/2022 10:52:53 AM