


- NOTES:
- ALL SEWER SERVICES SHALL BE 4" SDR 35 PVC @ 2.0% (MIN) U.N.O.
  - ALL WATER SERVICES SHALL BE 1" TYPE 'K' COPPER U.N.O.

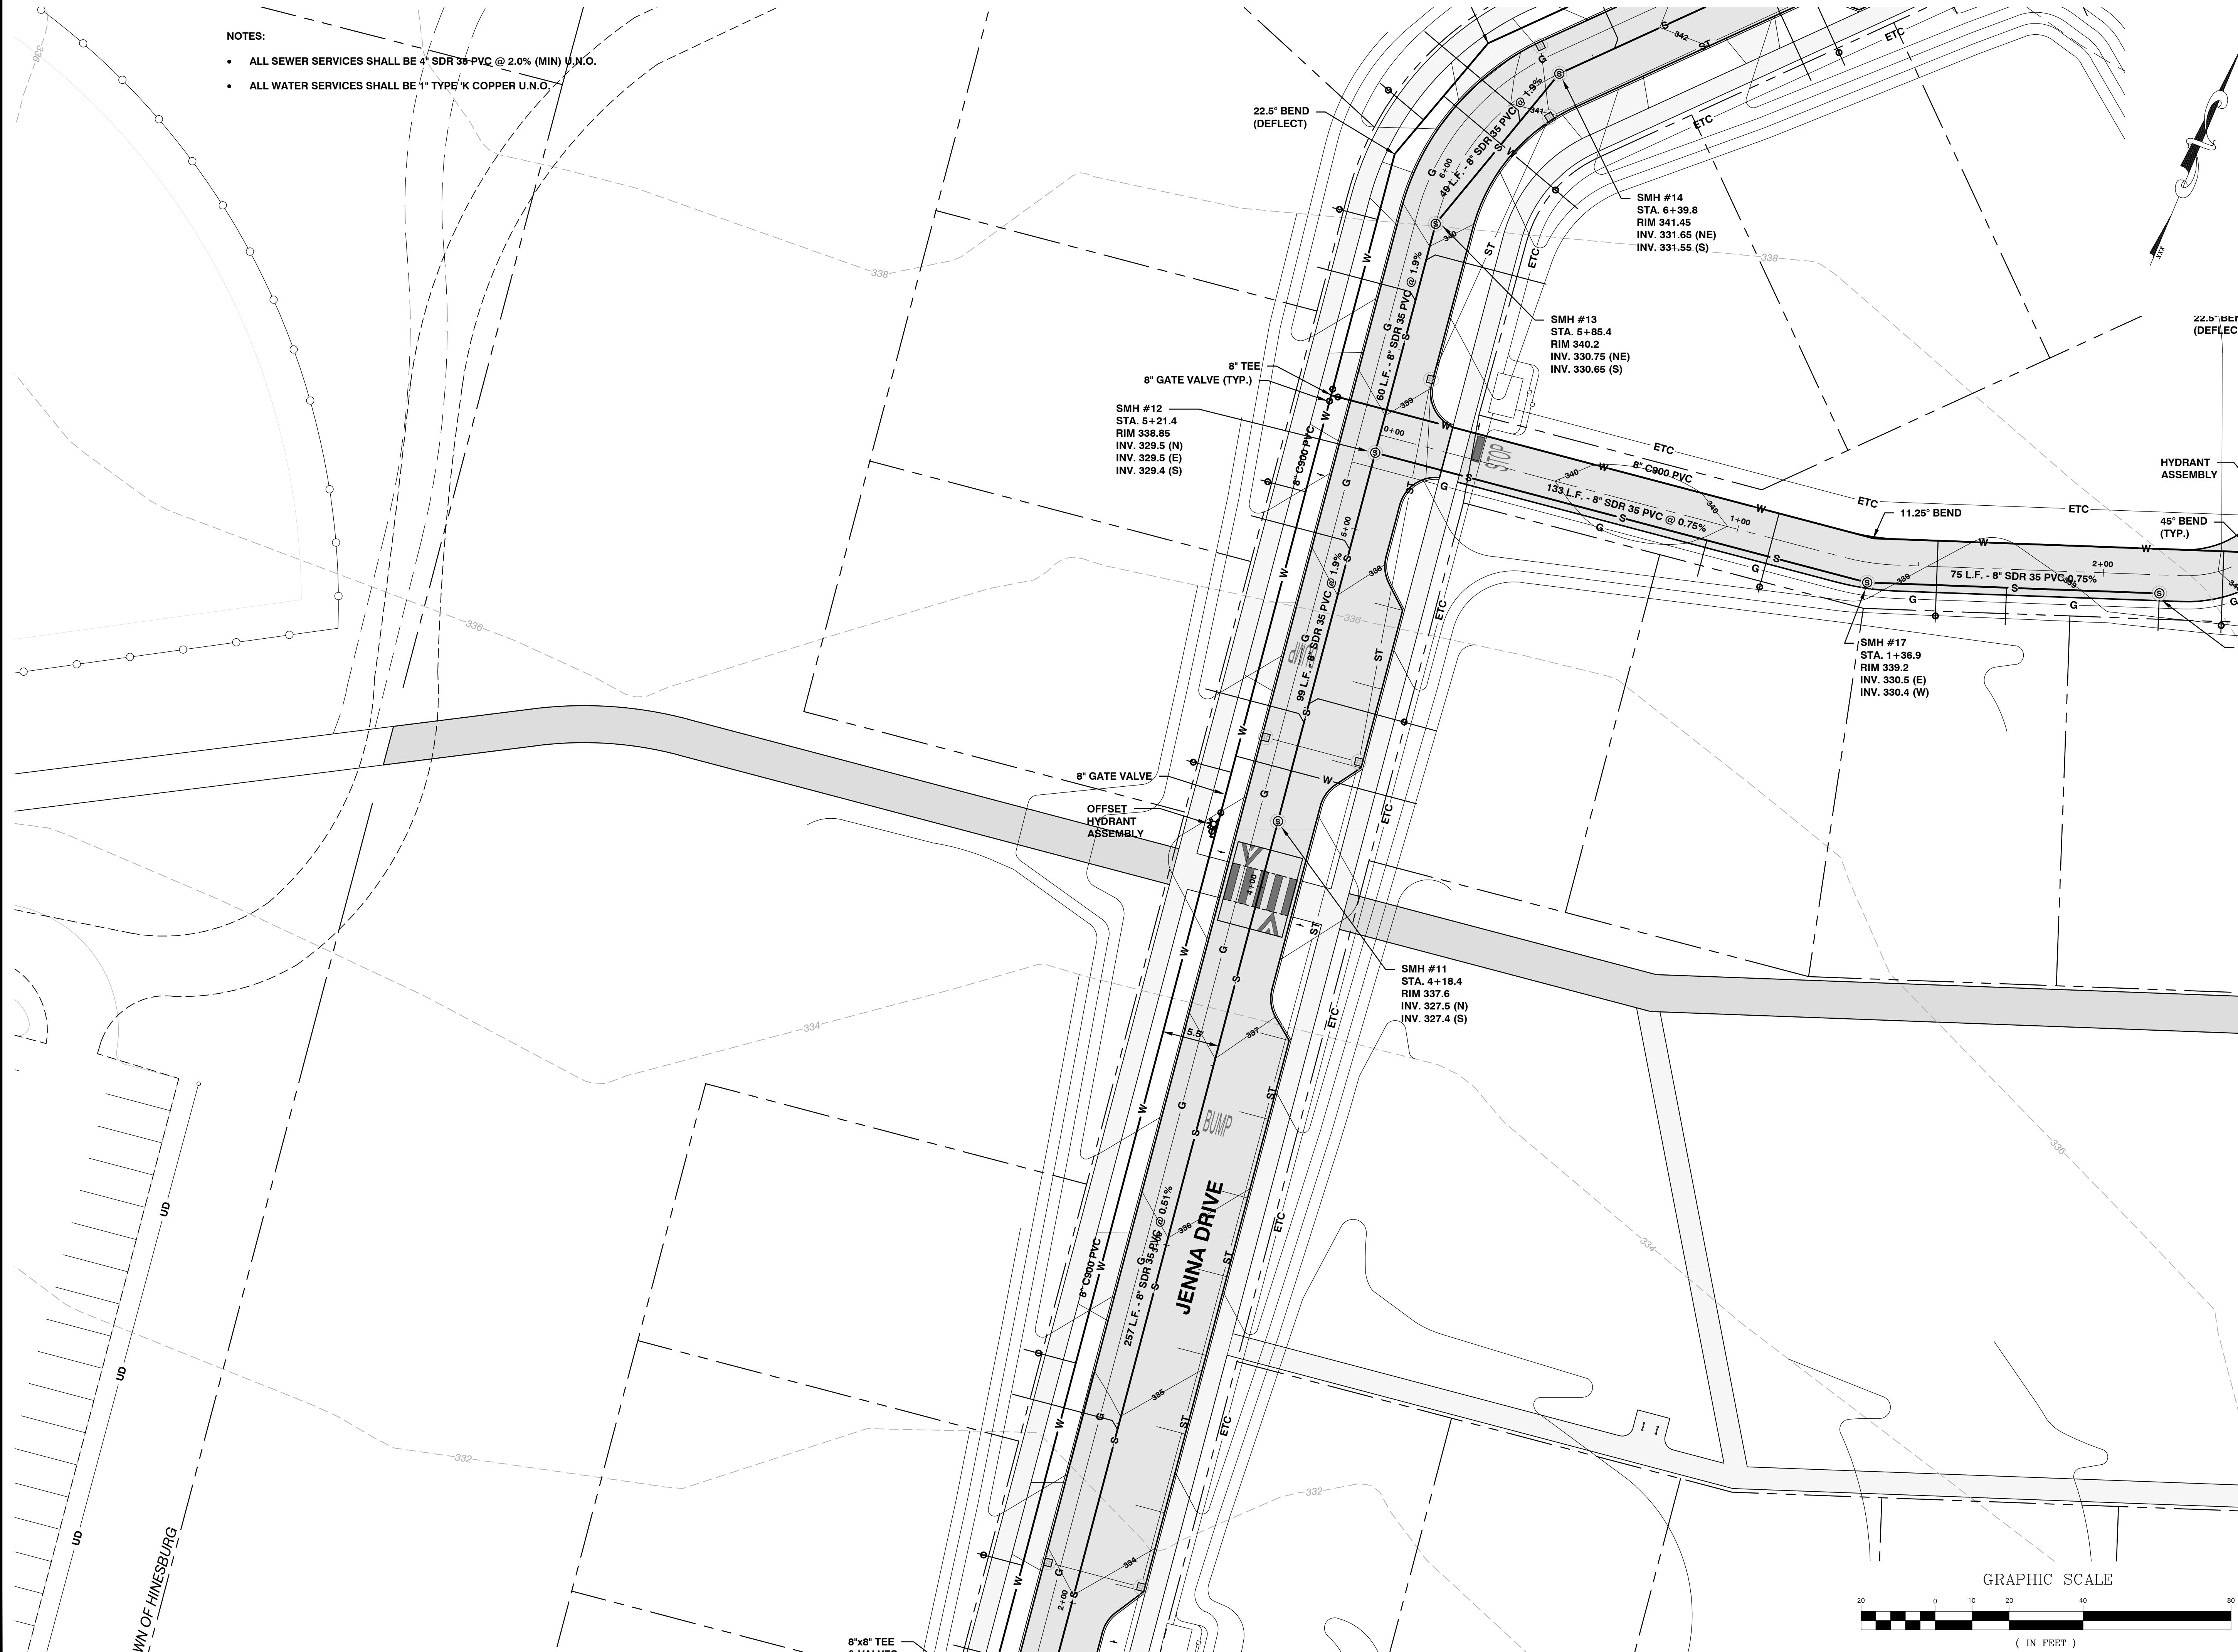

SITE ENGINEER:



CIVIL ENGINEERING ASSOCIATES, INC.  
10 MANSFIELD VIEW LANE, SOUTH BURLINGTON, VT 05403  
802-864-2323 FAX: 802-864-2271 web: www.ceai-vt.com

COPYRIGHT © 2019 - ALL RIGHTS RESERVED

DRAWN  
SAL  
CHECKED  
DSM  
APPROVED  
DSM

OWNER:  
**HAYSTACK  
CROSSING, LLC**  
c/o JOSEPH BISSONETTE


68 RANDALL STREET  
SOUTH BURLINGTON, VT 05403

APPLICANT:  
**BLACKROCK  
CONSTRUCTION, LLC**

68 RANDALL STREET  
SOUTH BURLINGTON, VT 05403

PROJECT:  
**HAYSTACK  
CROSSING**

SHELBURNE FALLS ROAD  
VERMONT ROUTE 116  
HINESBURG, VERMONT 05461

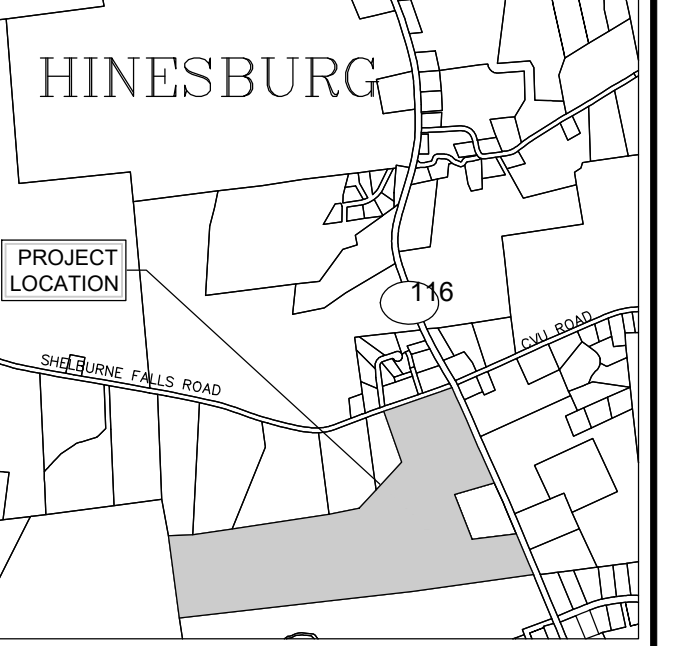

LOCATION MAP  
1" = 2000'

DATE	CHECKED	REVISION
11/22/19	DSM	TOWN RESUBMITTAL
1/10/20	DSM	UPDATE PER TOWN COMMENTS
3/4/22	DSM	REV. PER CONDITIONS OF APPROVAL

**PARTIAL SITE PLAN  
WATER & SEWER**

DATE  
**OCT. 4, 2019**  
SCALE  
1" = 20'  
PROJ. NO.  
13127

DRAWING NUMBER  
**C4.7**

